


FOR DETAIL OF THIS AREA  
SEE DWG. KEY-EL-02.

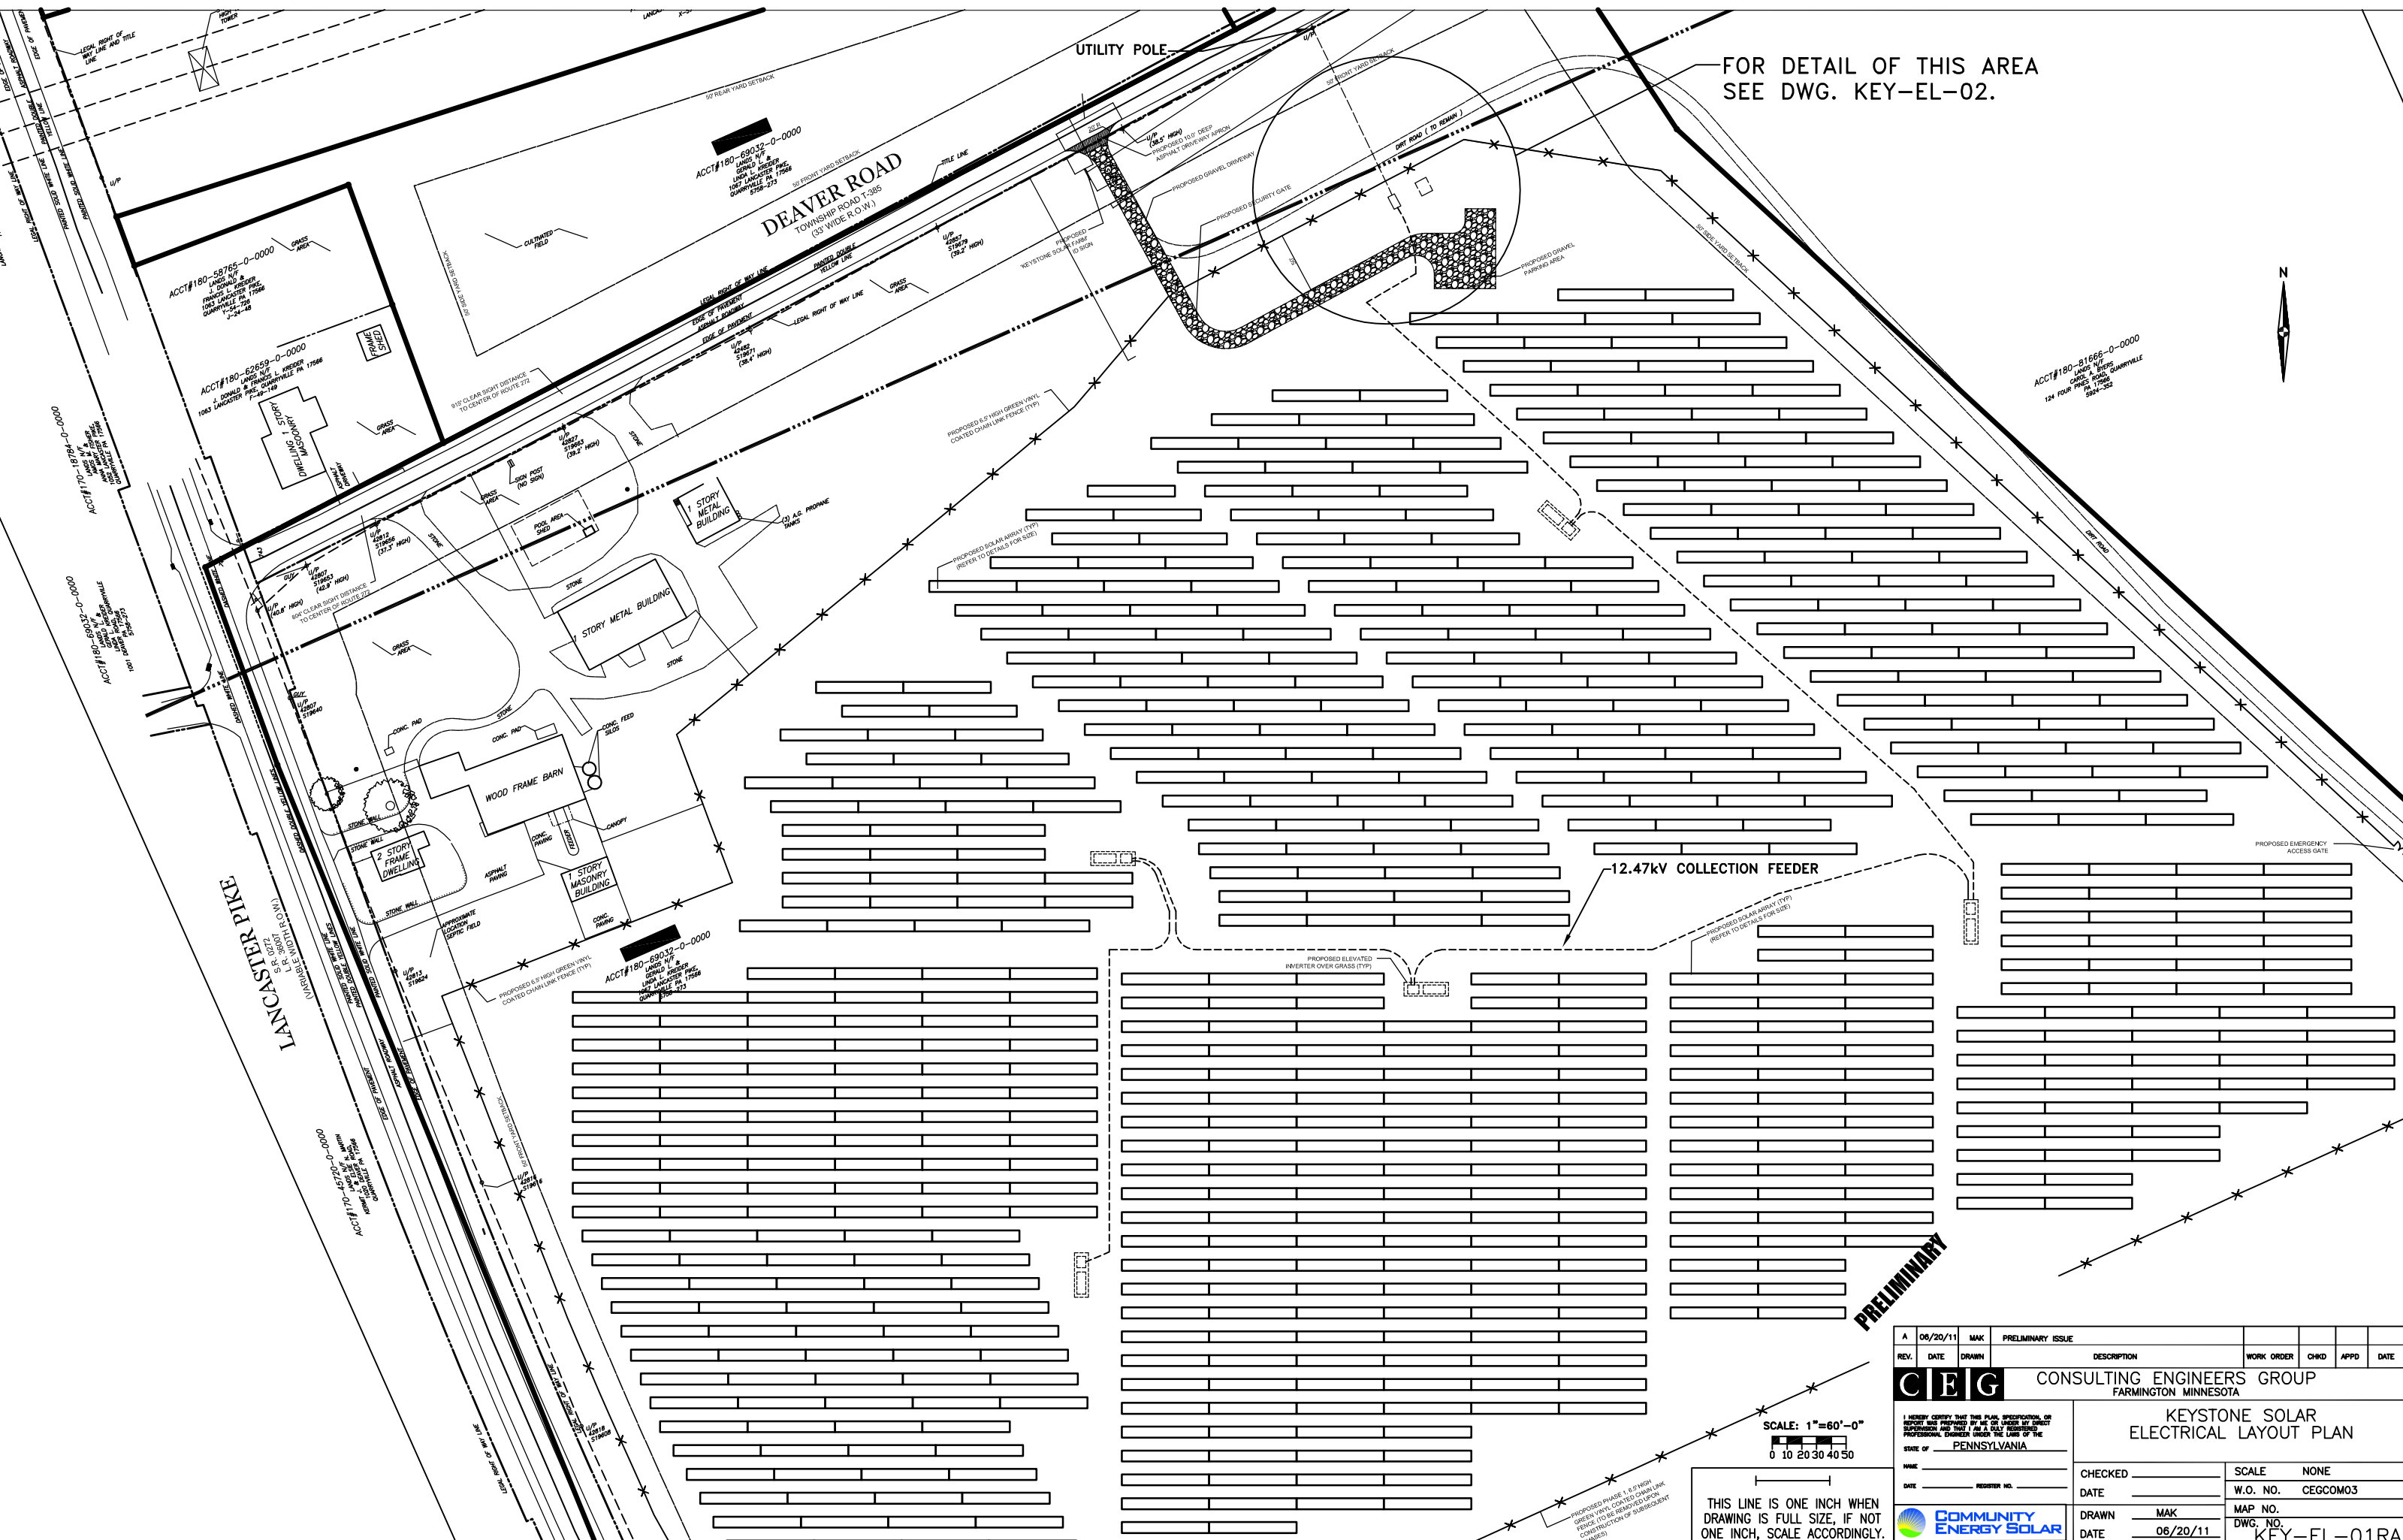

**PRELIMINARY**

SCALE: 1"=60'-0"  
0 10 20 30 40 50

THIS LINE IS ONE INCH WHEN  
DRAWING IS FULL SIZE, IF NOT  
ONE INCH, SCALE ACCORDINGLY.

A	06/20/11	MAK	PRELIMINARY ISSUE				
REV.	DATE	DRAWN	DESCRIPTION	WORK ORDER	CHKD	APPD	DATE
			<b>CONSULTING ENGINEERS GROUP</b> FARMINGTON MINNESOTA				
I HEREBY CERTIFY THAT THIS PLAN, SPECIFICATION, OR REPORT WAS PREPARED BY ME OR UNDER MY DIRECT PROFESSIONAL SUPERVISION AND TO THE BEST OF MY KNOWLEDGE AND BELIEF IT COMPLIES WITH ALL APPLICABLE REQUIREMENTS OF THE PENNSYLVANIA PROFESSIONAL ENGINEERING ACT.			<b>KEYSTONE SOLAR ELECTRICAL LAYOUT PLAN</b>				
NAME _____			SCALE NONE		W.O. NO. CEGCOM03		
DATE _____			REGISTER NO. _____		CHECKED _____		
DATE _____			DRAWN MAK		MAP NO. _____		
DATE _____			DATE 06/20/11		DWG. NO. KEY-EL-01RA		

